


COOPER CONSULTING

320 W. 100 S.
ORANGEVILLE UT, 84637
PHONE: 435-748-2378
CELL: 916-548-7506
FAX: 435-748-2378
email: cooper@sbcbglobal.net

DESIGN & DRAFTING SERVICES

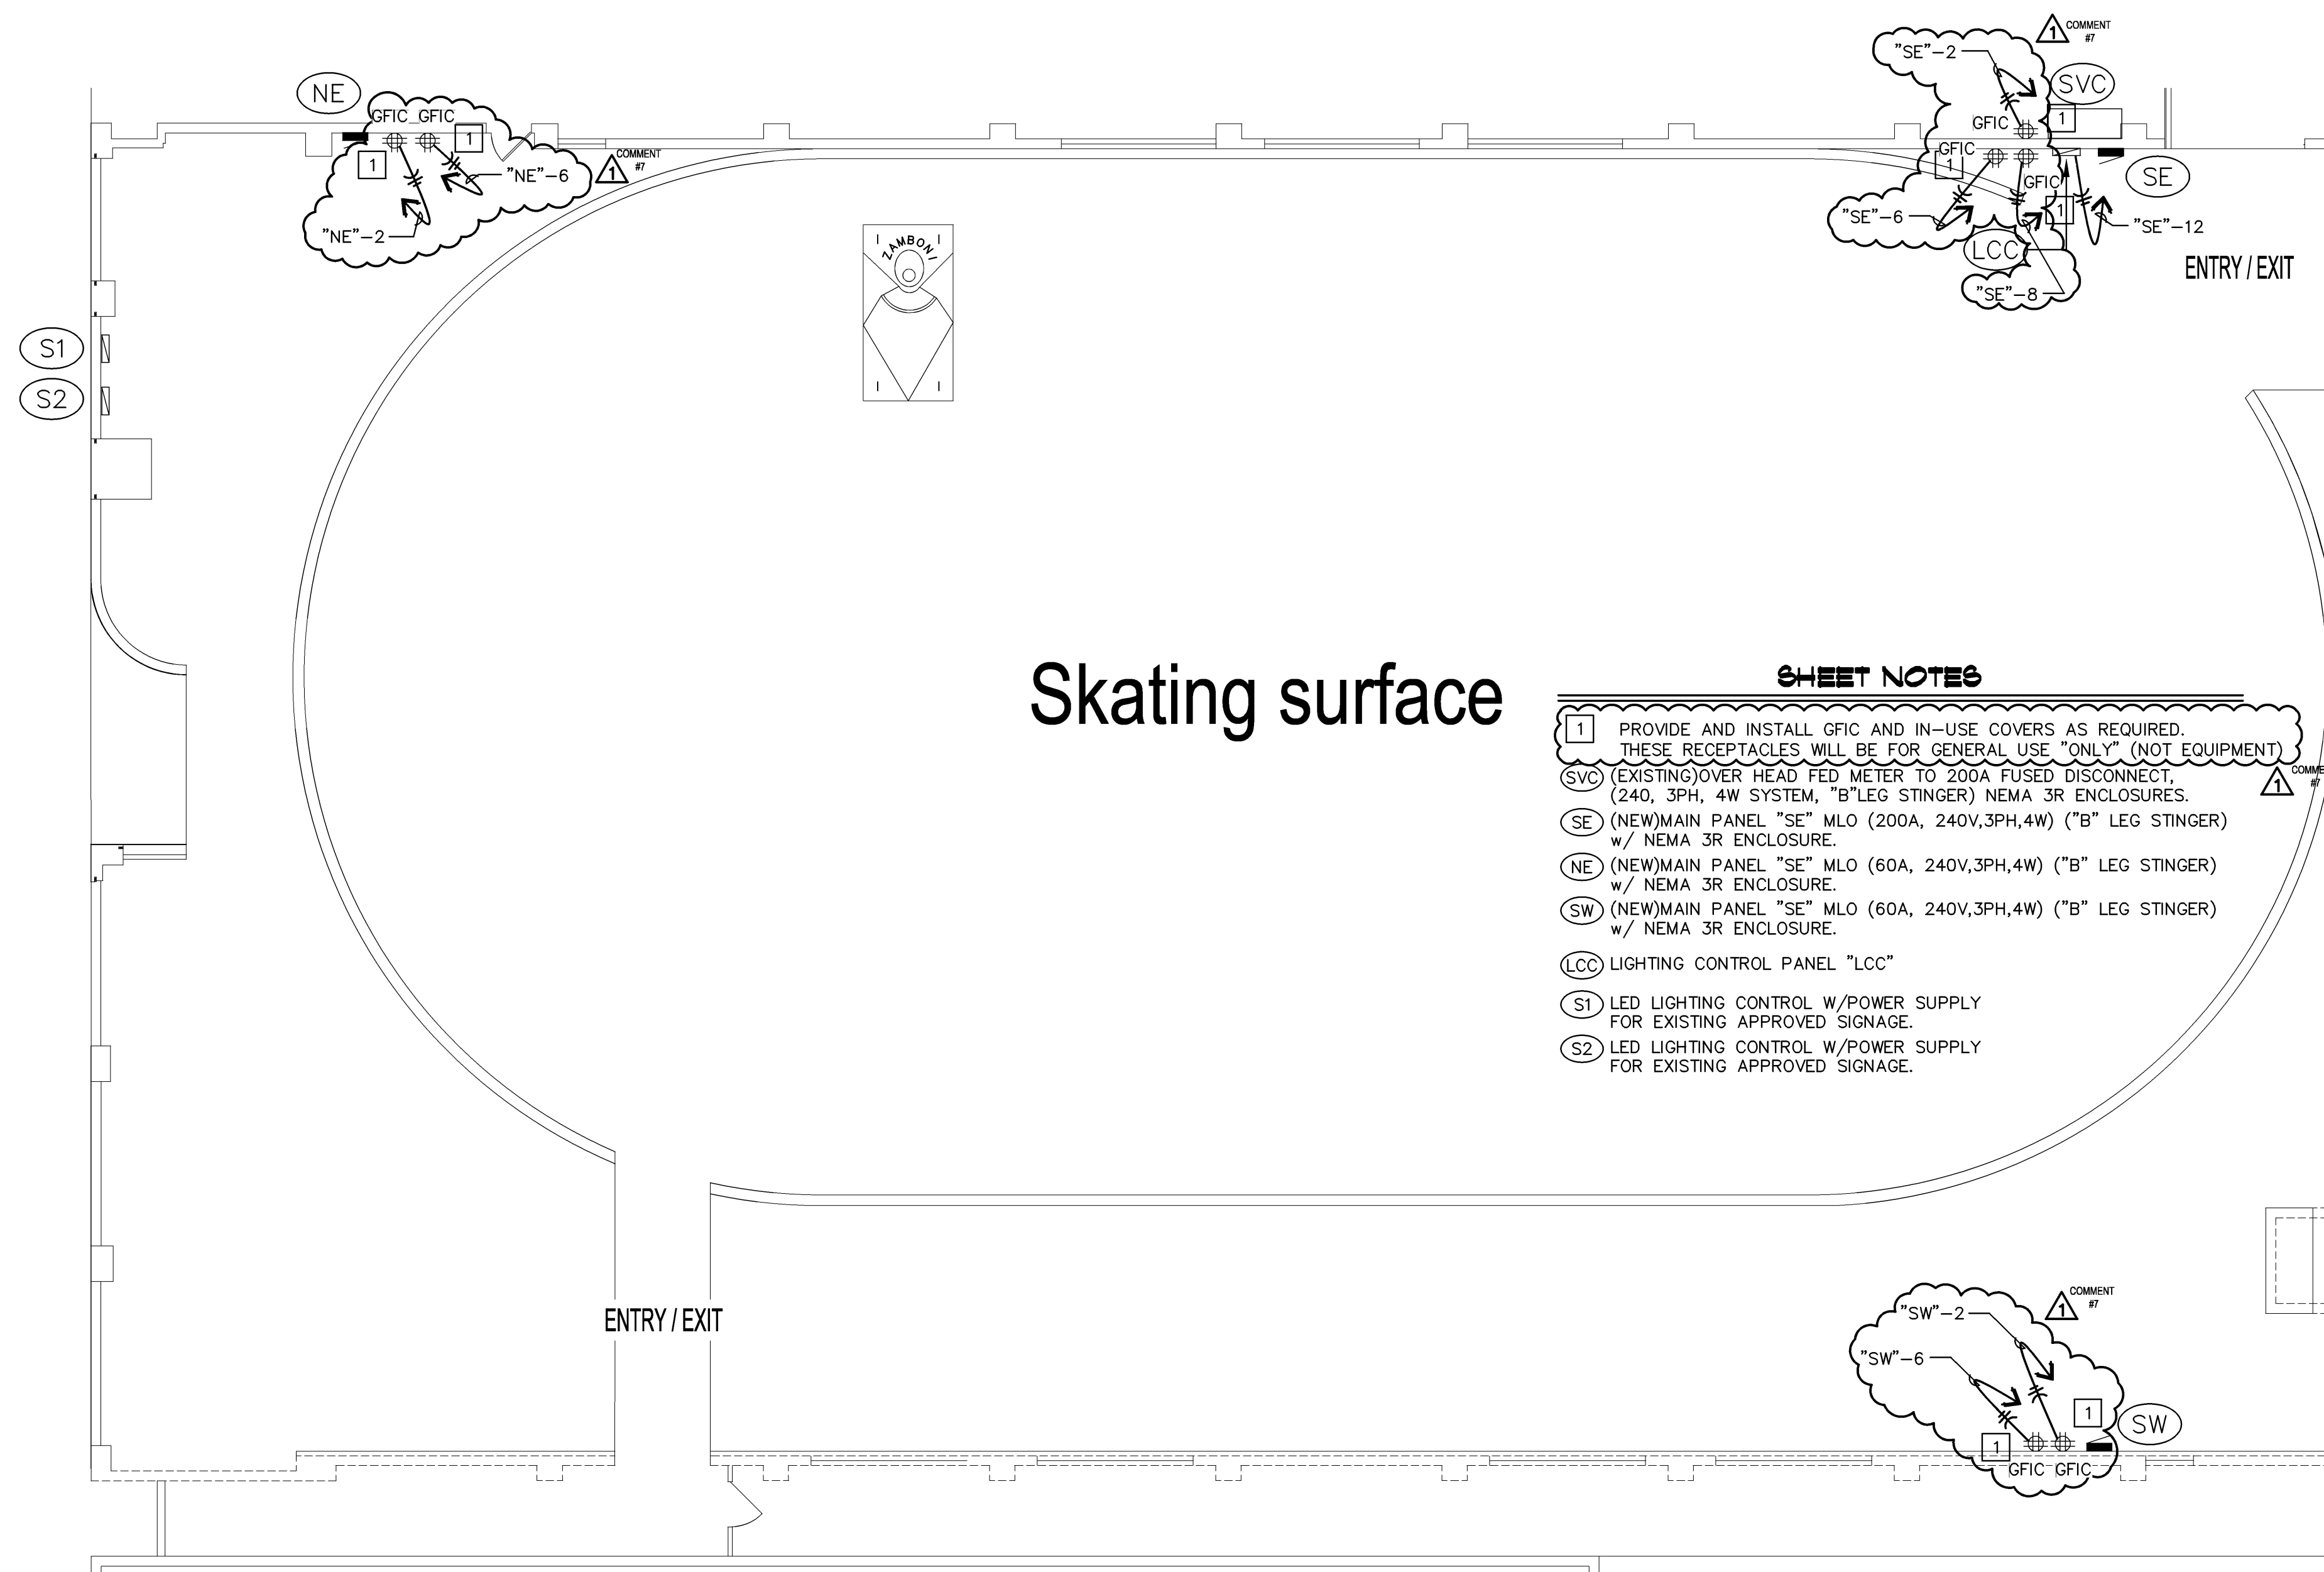

ELECTRICAL FLOOR PLAN- POWER & SIGNAL
(E)BUILDING, 1430 DEL PASO ROAD, SACRAMENTO, CA

SCALE: 1/8" = 1'-0"

NOTES TO CONTRACTOR

1. VERIFY ALL EQUIPMENT LOCATIONS WITH OWNER/ MANAGER PRIOR TO ROUGH-IN.
2. VERIFY NEMA CONFIGURATIONS WITH SPECIAL RECEPTACLES PRIOR TO ROUGH-IN.
3. SWITCHES MAY NEED TO BE RELOCATED DUE TO THE DEMOLITION OF WALLS OR PARTITIONS THAT MAY COVER (EXISTING) LOCATIONS.
4. SECURITY & CCTV IS NOT SHOWN BUT SHOULD BE COORDINATED WITH ASSOCIATED CONTRACTORS PRIOR TO ELECTRICAL WORK. AND IS IN NO PART OF SCOPE FOR WILLS BROTHERS ELECTRIC.
5. COORDINATE ALL WORK WITH ARCHITECTURAL NOTES & PLANS PRIOR TO ANY ELECTRICAL WORK.
6. COORDINATE EXACT LOCATIONS FOR RECEPTS & DATA AS REQUIRED.

NOTES TO PLAN CHECKER

SCOPE

1. THIS IS A SINGLE STORY, (REMODEL) FIRE RESTORATION OF SKATING RINK. NO ROOF ON BUILDING, WALLS ONLY. THE INSTALLATION OF NEW SERVICE PANEL "SVC" AS SHOWN. 240/120, 3PH, 4W 200AMP METER & MAIN. INSTALLATION OF (1) MAIN PANEL INSIDE OF WALL, 200A, 120/240V, 3PH, 4W SYSTEM "B" LEG "STINGER". INSTALLATION OF (2) SUB PANEL BOARDS SAME VOLTAGE & 60AMPS EACH. (SEE PANEL SCHEDULES)
2. THE INSTALLATION OF (7) QUAD TYPE RECEPTACLES (GFIC) w/IN-USE COVERS.
3. INSTALLATION OF SUMP PUMP NOT REQUIRED. OWNER WILL USE OUTSIDE SOURCE TO PUMP WATER WHEN REQUIRED.

STAMP

RESTORATION

ICELAND SKATING RINK

1430 DEL PASO ROAD
SACRAMENTO, CA 95818

PROJECT NAME/ADDRESS

February 11, 2011

PROJECT DATE

G. COOPER

DRAWN/DESIGNER

CHECKED

PLAN CHECK COMMENTS
JANUARY 11, 2011

REVISIONS/DATES

REVISIONS/DATES

ELECTRICAL
FLOOR PLAN
POWER & SIGNAL

SHEET TITLE

NEW SHEET

E1.1

SHEET 2 OF 5

ELECTRICAL CONTRACTOR TO PROVIDE AND INSTALL ALL ELECTRICAL EQUIPMENT TO THE 2010 CALIFORNIA ELECTRICAL CODE AND THE 2008 CALIFORNIA ENERGY CODE PER TITLE 24 STANDARDS.