


Del Paso Boulevard

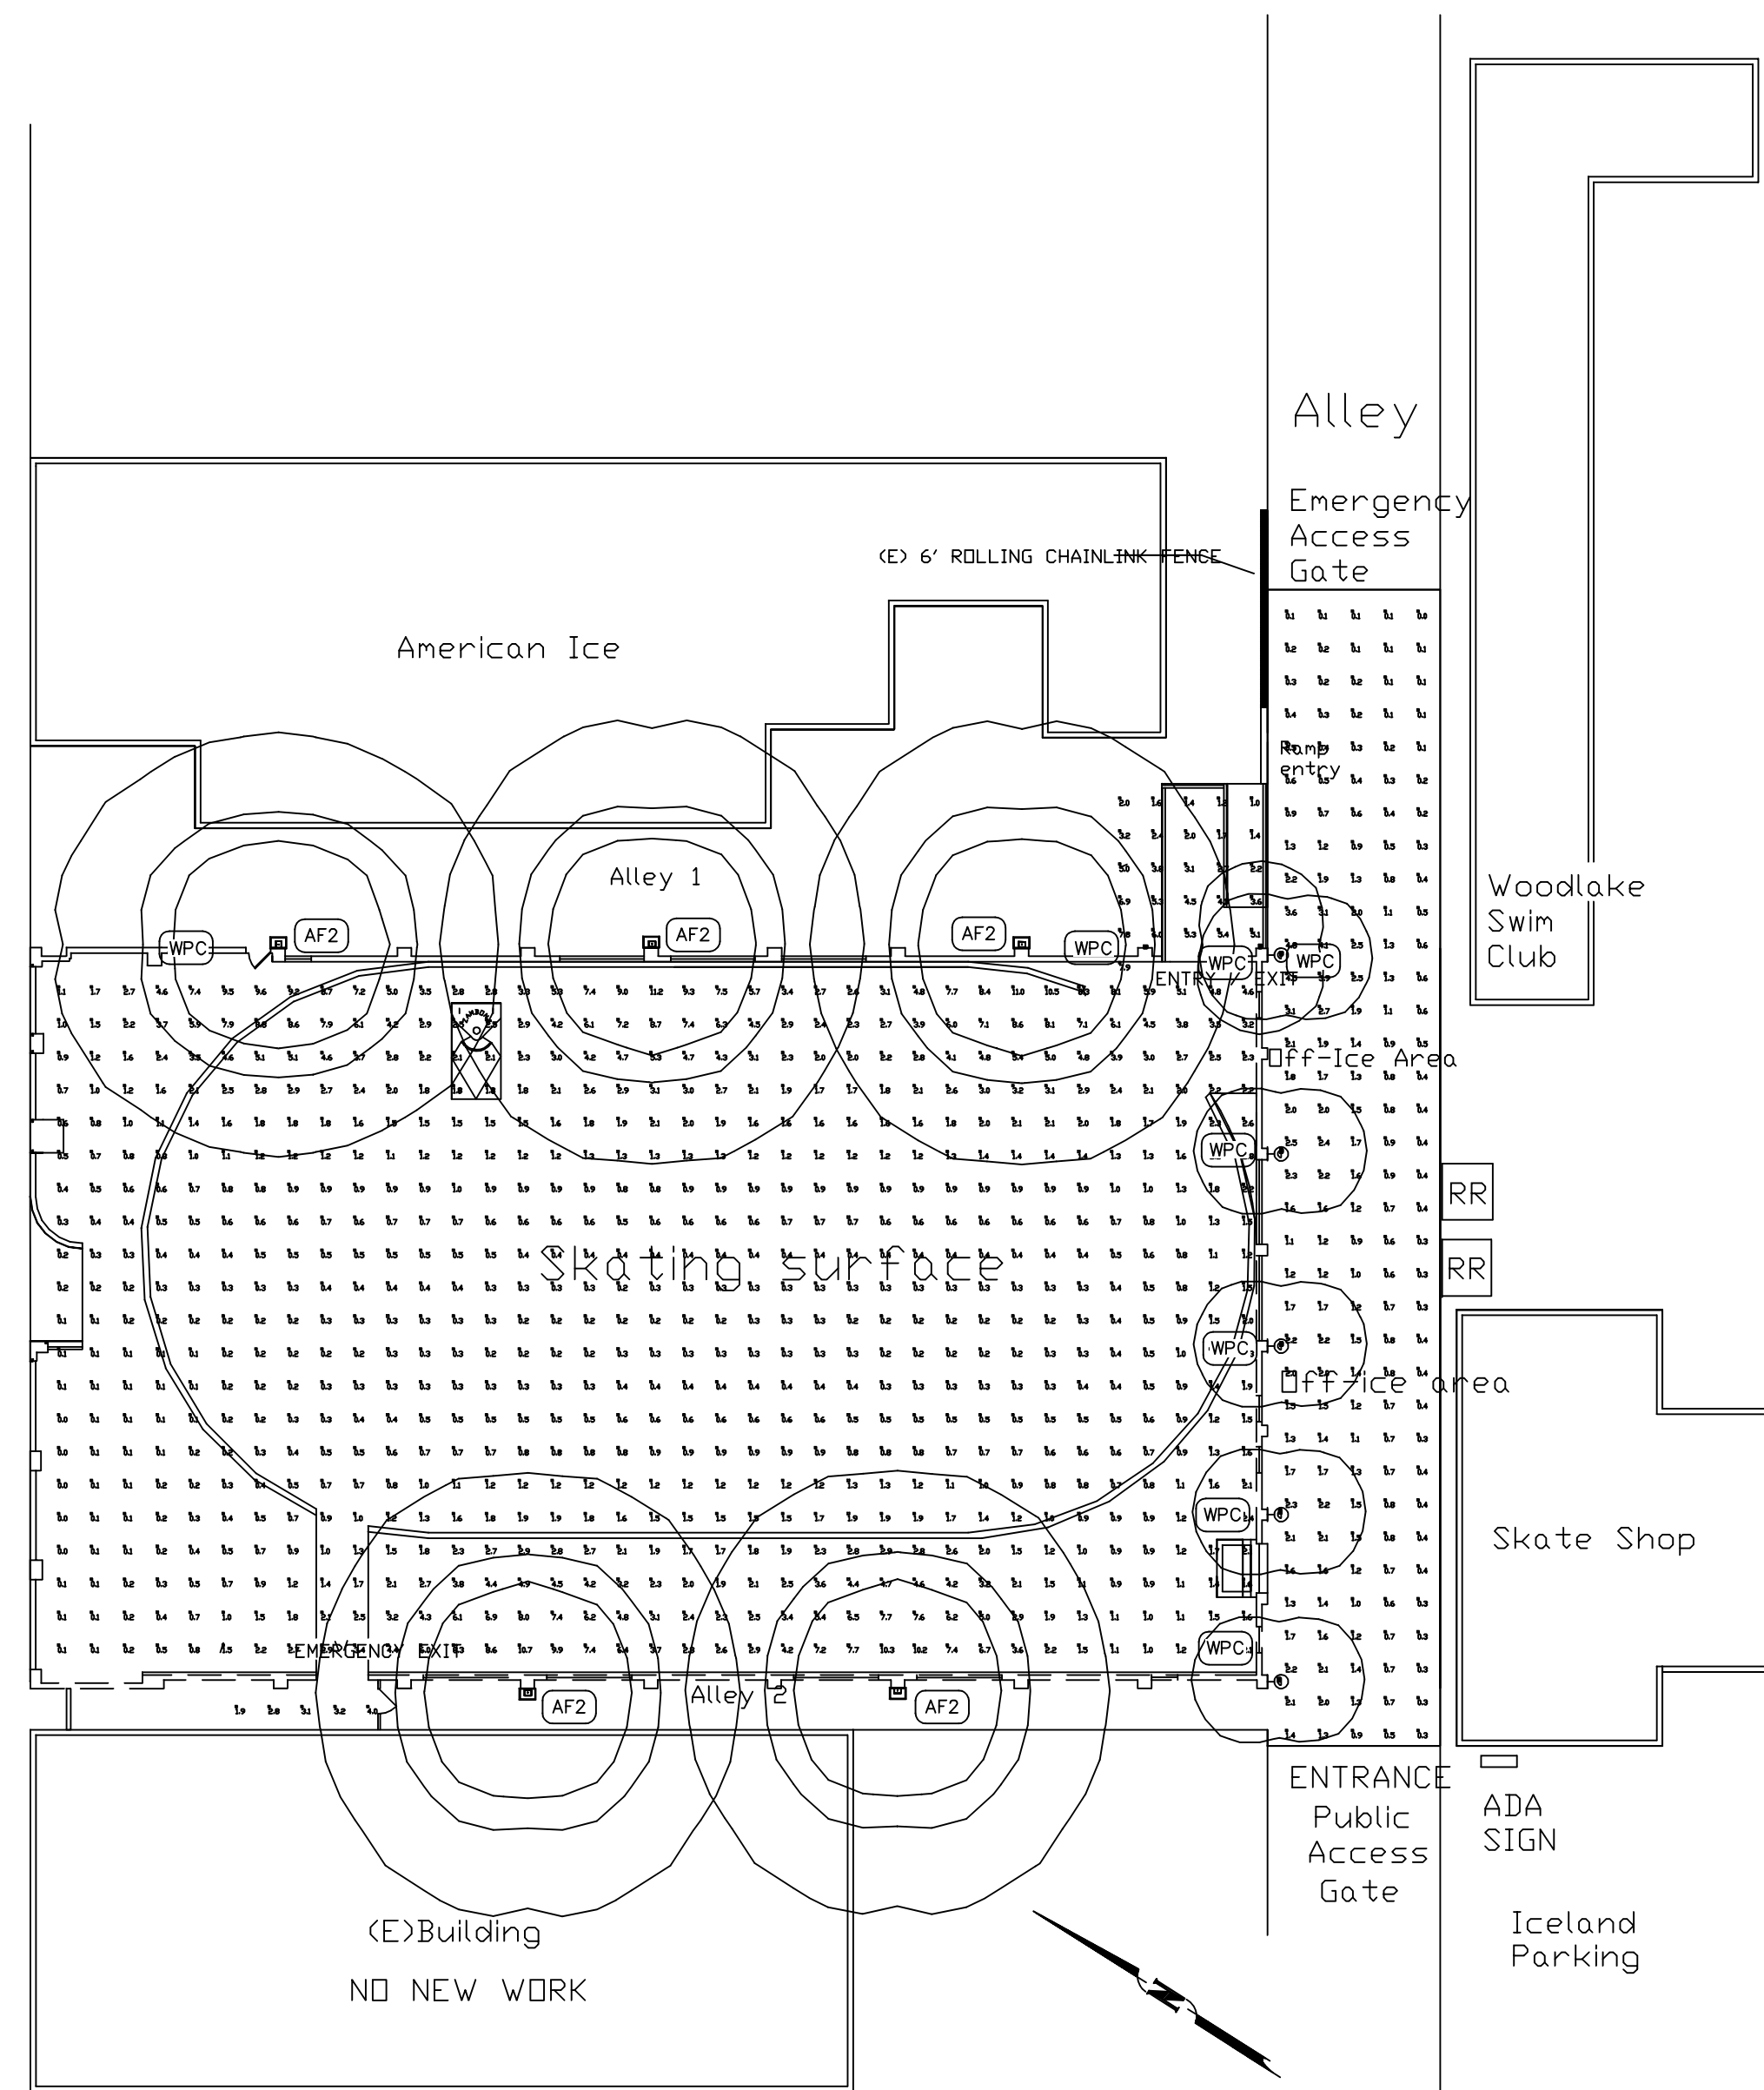

E2.2 ELECTRICAL SITE PLAN- PHOTOMETRICS
 SCALE: 1/16" = 1'-0"
 FEBRUARY 03, 2011

Numeric Summary - Basic									
Project All Projects									
Label	CalcType	Units	Avg	Max	Min	Avg/Min	Max/Min		
Rink Area	Illuminance	Fc	1.80	115	0.0	0.00	0.00		
Office Area	Illuminance	Fc	113	4.8	0.0	0.00	0.00		
East Rk Area	Illuminance	Fc	7.86	107	4.3	1.83	24.9		
East Rk	Illuminance	Fc	3.72	7.9	1.0	3.72	7.90		
West	Illuminance	Fc	4.55	8.2	1.9	2.99	4.32		

Luminaire Schedule									
Project All Projects									
Symbol	Qty	Label	Arrangement	Lumens	LLF	Description			
□	5	AF2	SINGLE	14000	1.000	Area Flood-250w PSM4			
□	6	WPCFL	SINGLE	1800	1.000	Wall-Peck CFL 42w			

Expanded Luminaire Location Summary										
Project All Projects										
Symbol	Label	X	Y	Z	Mount	Tilt	X-Amp1	Y-Amp1	Z-Amp1	TCF
□	WPCFL	189.879	148.914	12	0.162	0	189.879	148.914	0	1
□	WPCFL	189.879	124.921	12	0.162	0	189.879	124.921	0	1
□	WPCFL	189.879	101.462	12	0.162	0	189.879	101.462	0	1
□	WPCFL	189.746	81.069	12	0.162	0	189.746	81.069	0	1
□	WPCFL	189.613	66.675	12	0.162	0	189.613	66.675	0	1
□	AF2	64	150	25	0	0	64	150	0	1
□	AF2	113.998	150.889	25	0	0	113.998	150.889	0	1
□	AF2	158.262	150	25	0	0	158.262	150	0	1
□	AF2	98.307	59.077	25	0	0	98.307	59.077	0	1
□	AF2	143.026	59.344	25	0	0	143.026	59.344	0	1
□	WPCFL	187.382	149.789	12	0	0	187.382	149.789	0	1

PLAN CHECK COMMENTS
 JANUARY 11, 2011

ELECTRICAL
 SITE PLAN
 PHOTOMETRIC
 STUDY

NEW SHEET
E2.2

ELECTRICAL CONTRACTOR TO PROVIDE AND
 INSTALL ALL ELECTRICAL EQUIPMENT TO THE
 2010 CALIFORNIA ELECTRICAL CODE AND THE
 2008 CALIFORNIA ENERGY CODE PER TITLE 24
 STANDARDS.



COOPER CONSULTING
 320 W. 100 S.
 ORANGEVILLE UT, 84637
 PHONE: 435-748-2378
 CELL: 916-548-7508
 FAX: 435-748-2378
 email: cooper@cooperconsulting.net

DESIGN & DRAFTING SERVICES

STAMP

RESTORATION
ICELAND SKATING RINK
 1430 DEL PASO ROAD
 SACRAMENTO, CA 95815

PROJECT NAME/ADDRESS

February 11, 2011
 PROJECT DATE

G. COOPER
 DRAWN/DESIGNER

 CHECKED

REVISIONS/DATES

△ _____
 △ _____
 △ _____
 △ _____

SHEET TITLE

SHEET _____ OF _____