




TYPICAL CONNECTION
SUPPLY HEADER
Scale - 1" = 1'-0"

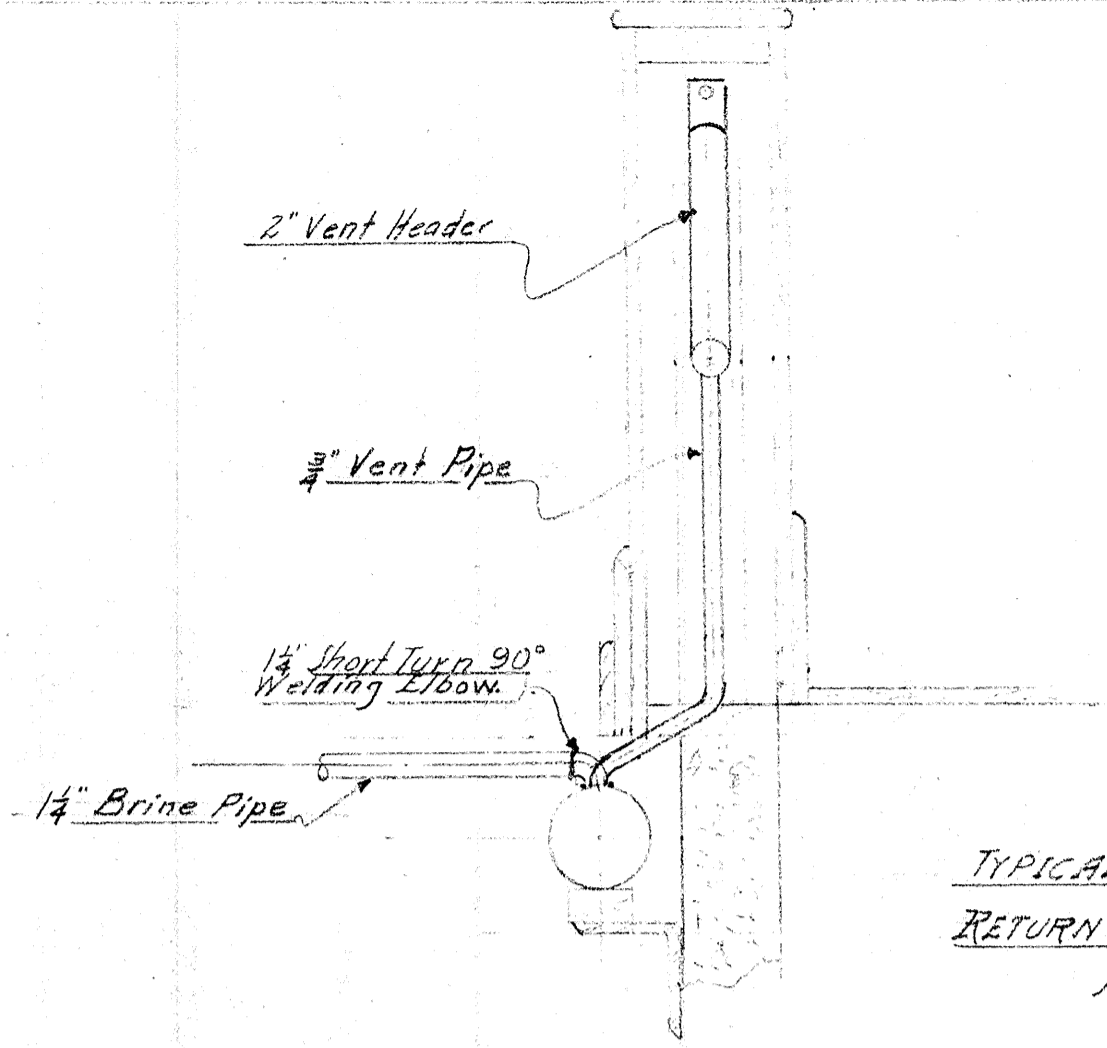

TYPICAL CONNECTION
RETURN HEADER & VENT
Scale - 1" = 1'-0"

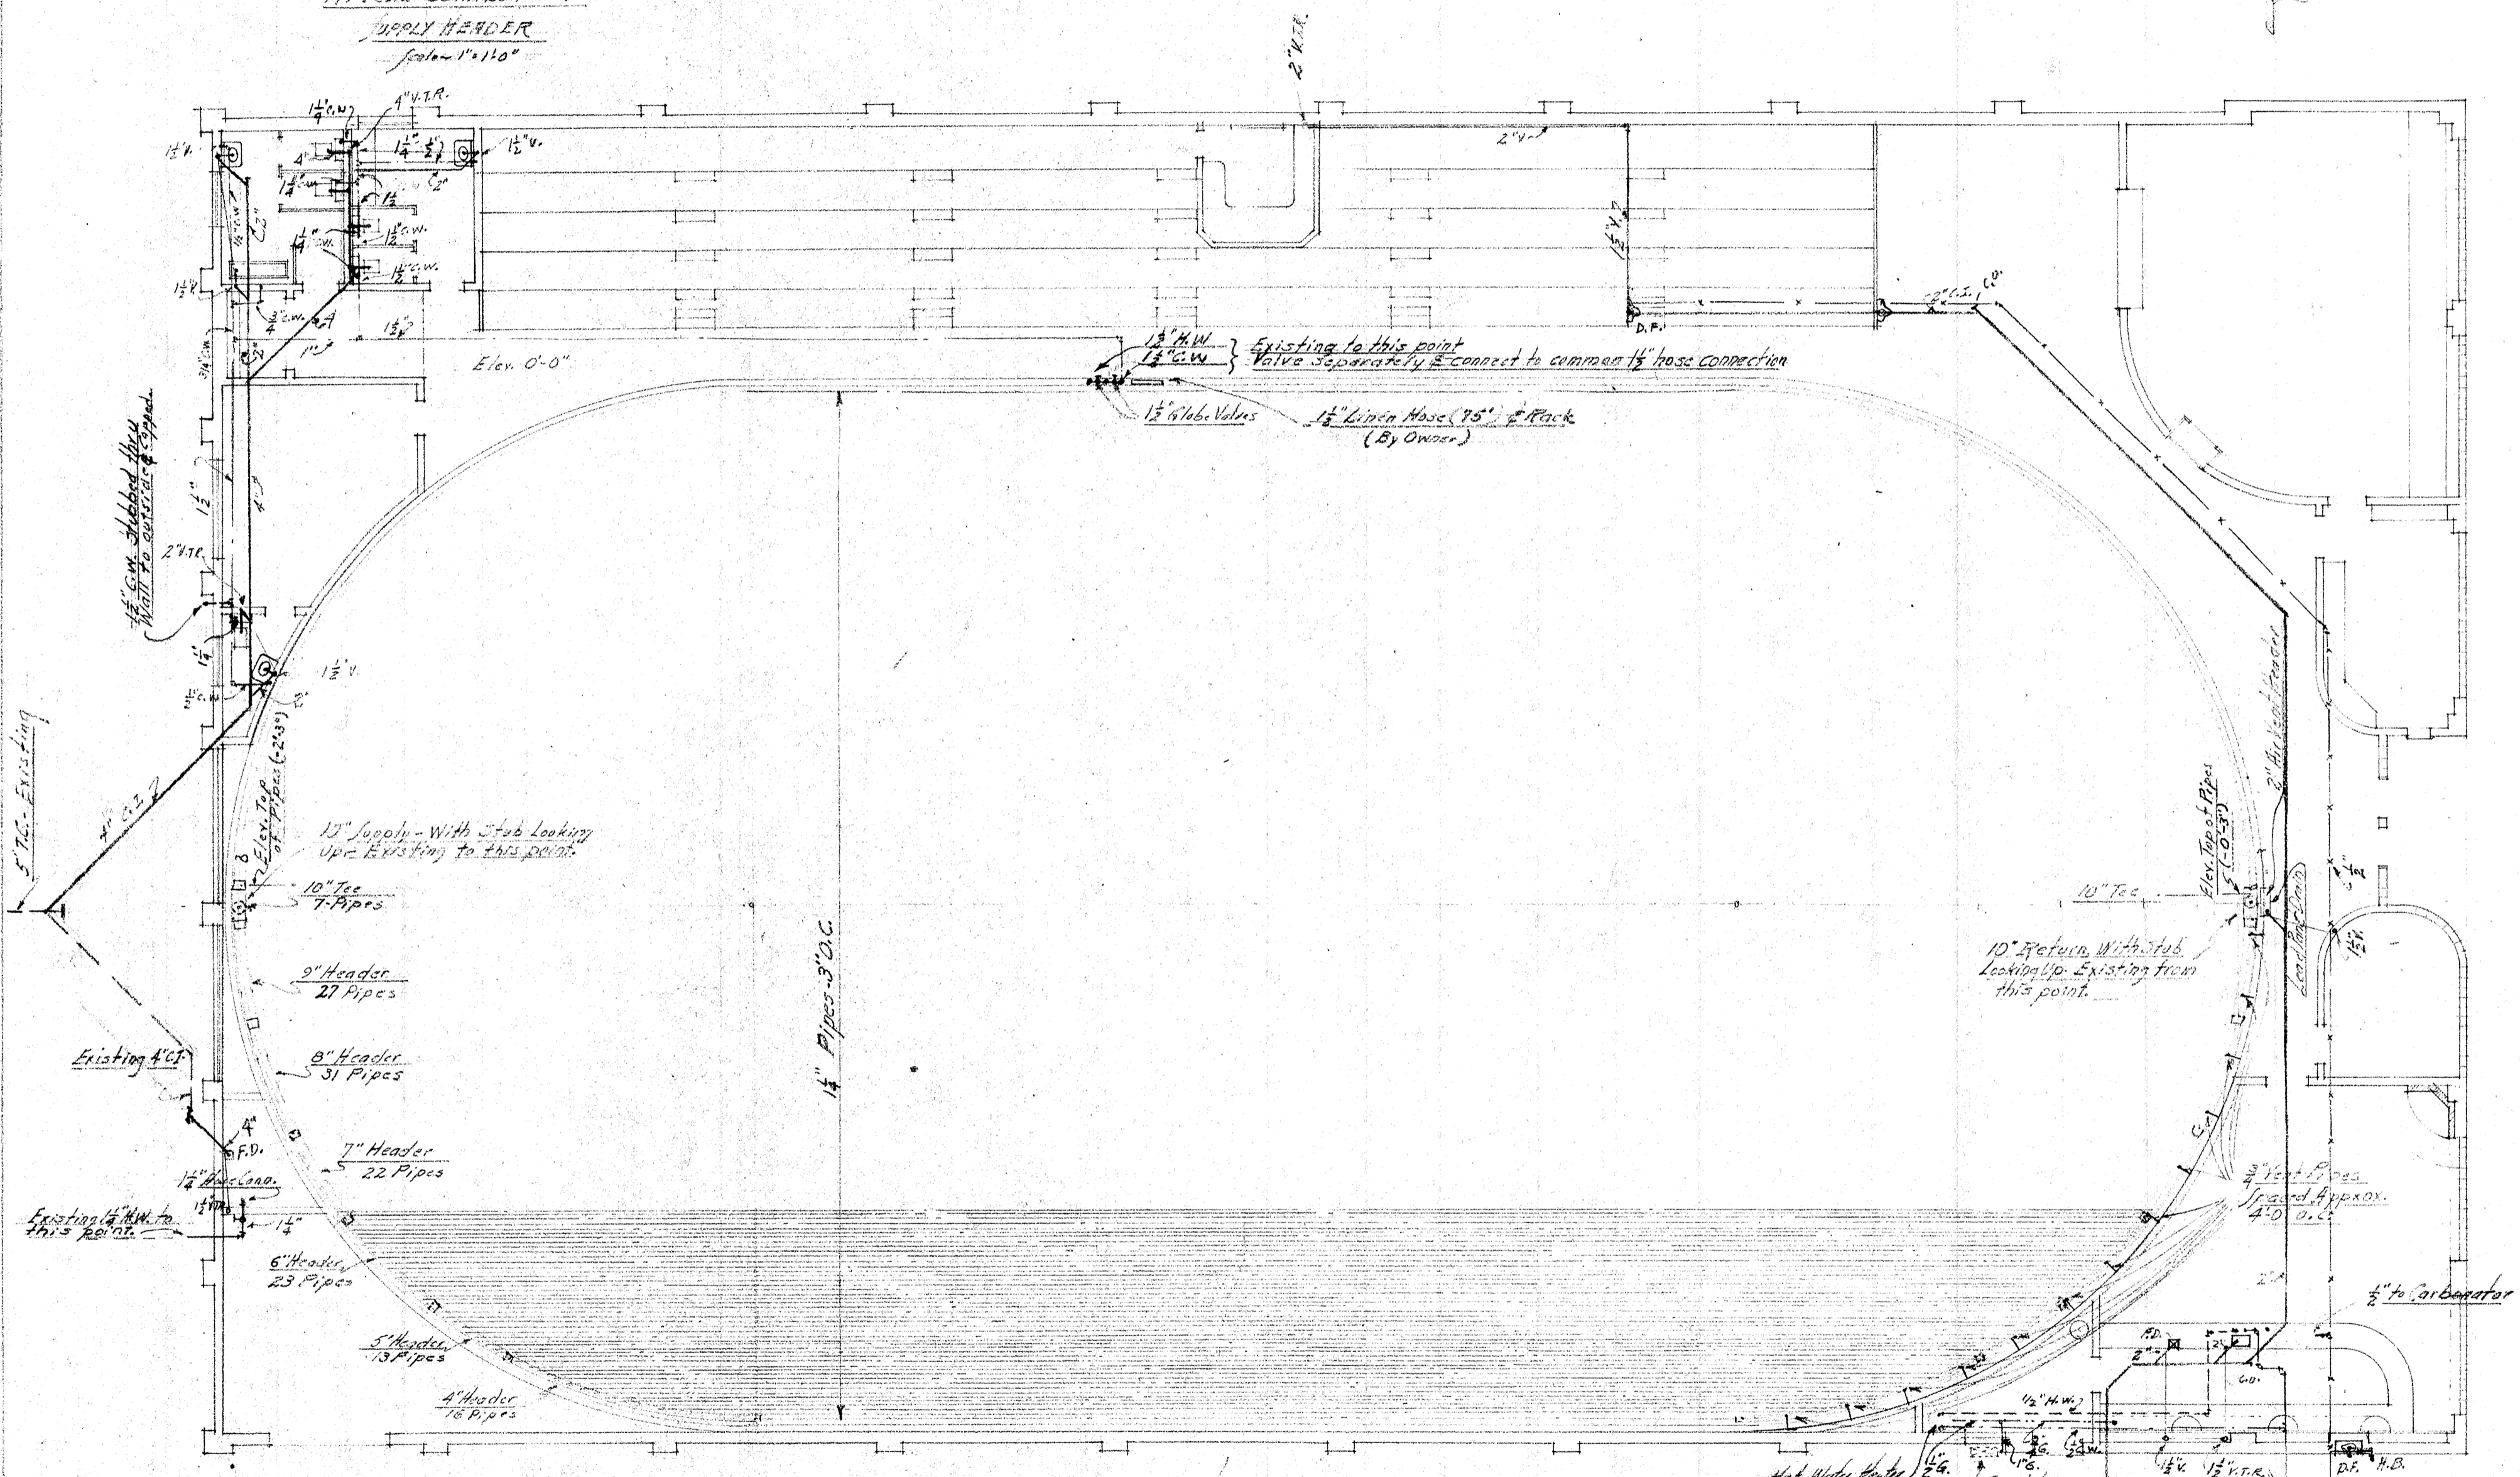

PLUMBING PLAN
3/8" Scale

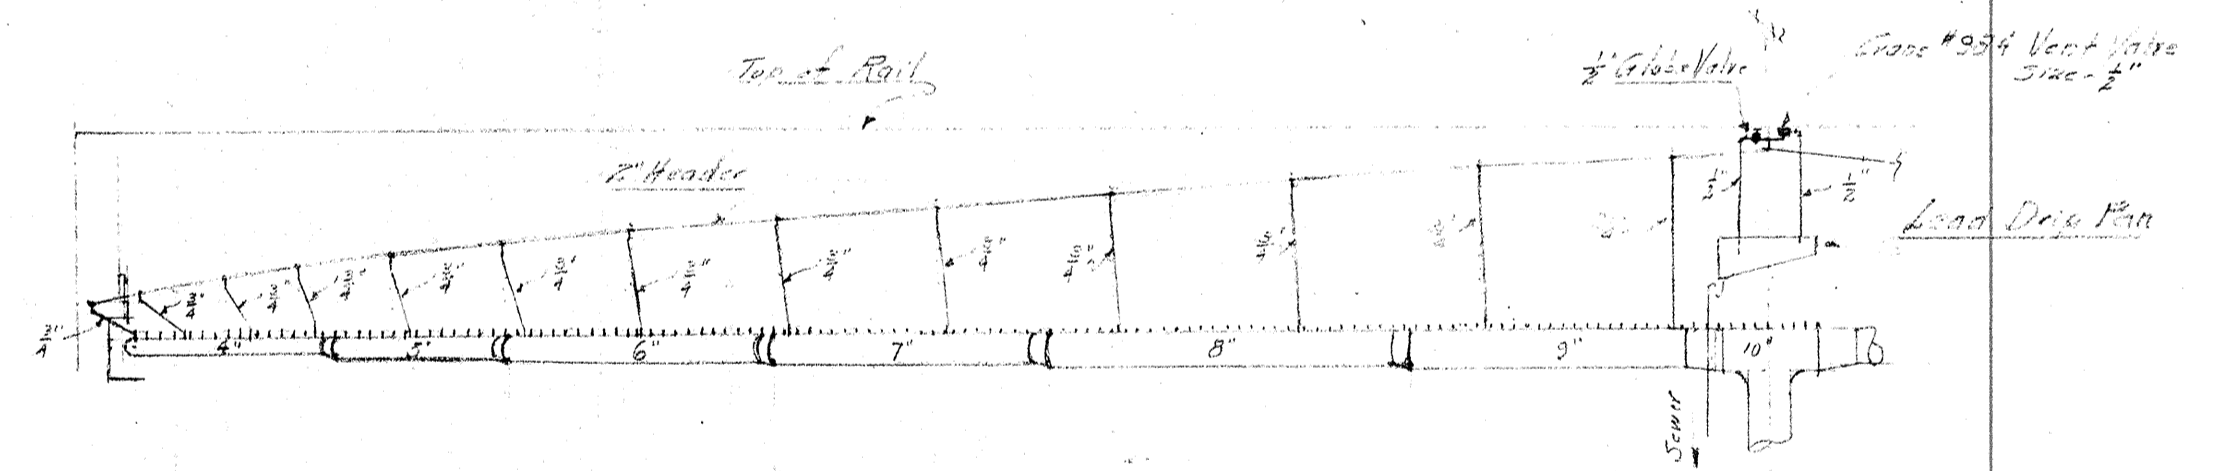

HALF END VIEW SHOWING RETURN HEADER
& AIR VENT HEADER CONNECTIONS.

ICELAND SKATING RINK
 FOR
 MR. W. J. KERTH
 1430 DEL PASO BLVD. NORTH SACRAMENTO
 CHAS. F. DEAN ARCHT. & ENGR.
 SACRAMENTO

Sheet
 No. 20440
 No. 20440